


1 TYPICAL WIRING SMOKE/CO DETAIL
SCALE: N.T.S

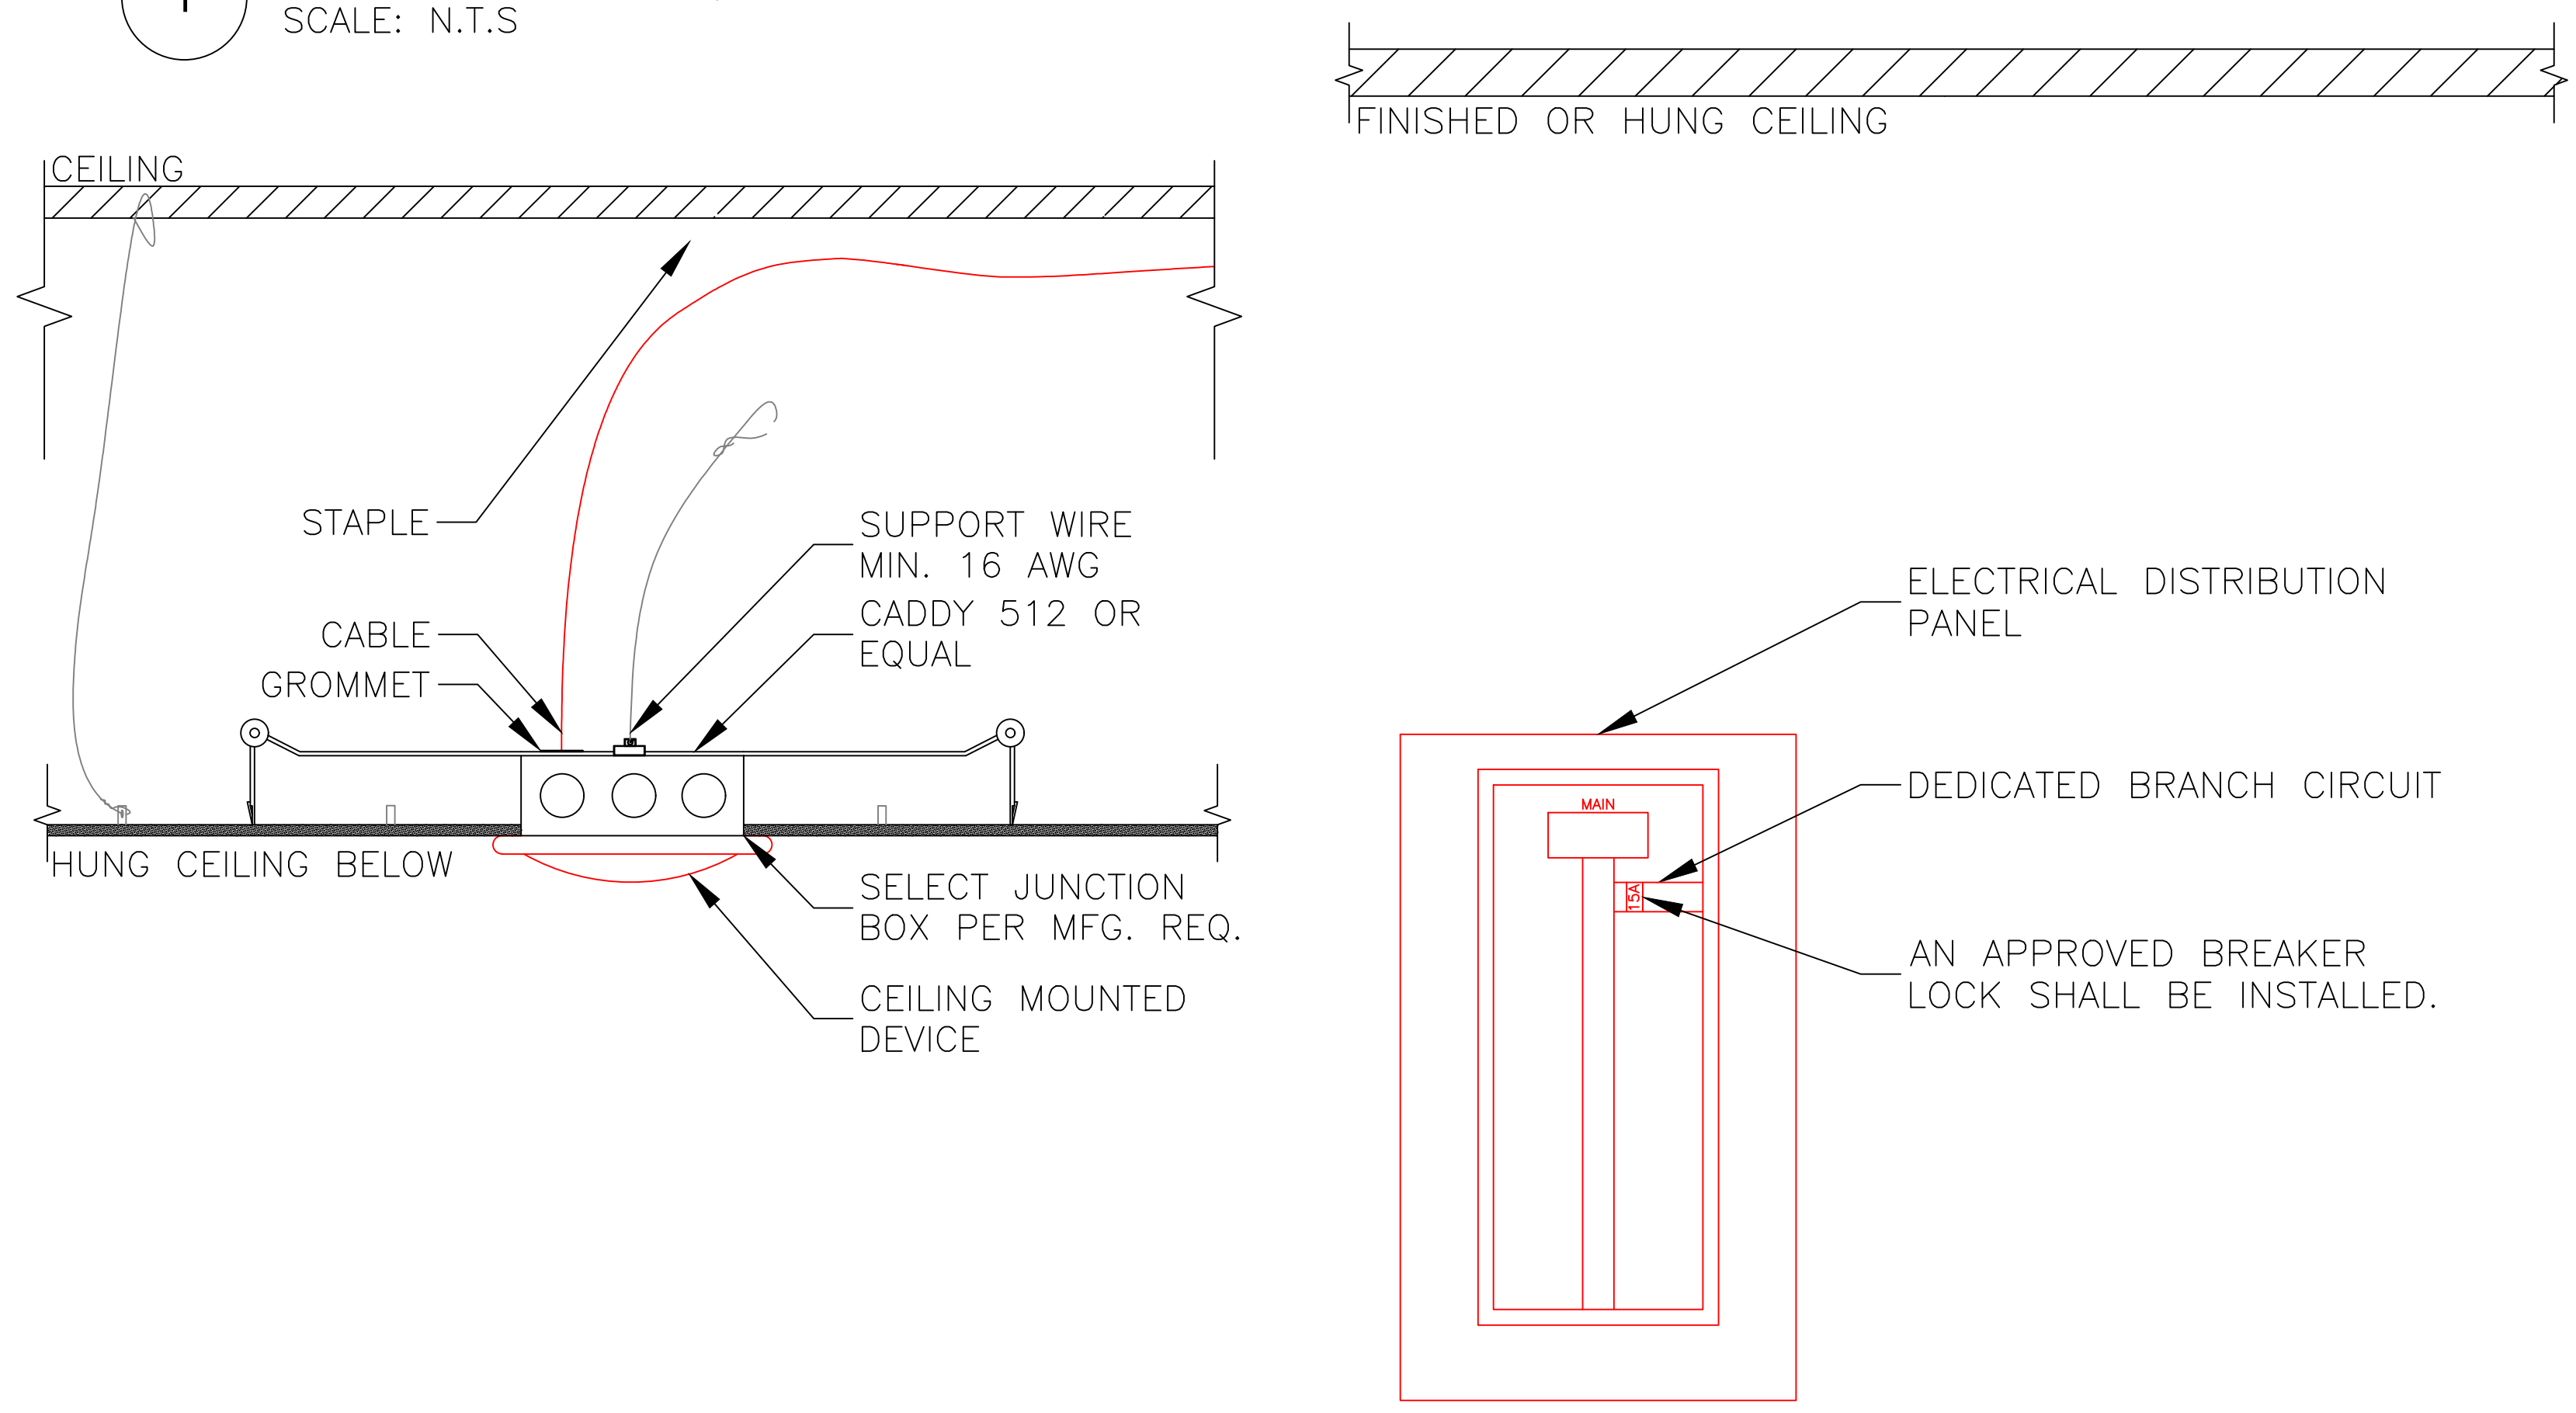

2 HUNG CEILING DEVICE MOUNTING
SCALE: N.T.S

3 SMOKE ALARM DEDICATED BRANCH CIRCUIT
SCALE: N.T.S

PROJECT INFORMATION	
ALAN HENDERSON	
INSTALLATION CONTRACTOR INFO.	
PEACE OF MIND FIRE & SECURITY SAFETY LLC 167 MIDDLETOWN AVE. NORTH HAVEN, CT 06473 203-901-4350	
NICET CERTIFIED DESIGNER INFORMATION	
JOSEPH MONTUORI, SET (FIRE ALARM SYSTEMS LEVEL IV) 167 MIDDLETOWN AVE. NORTH HAVEN, CT 06473 NICET ID #: 137011	
DRAWING TITLE	
DETAILS	
SCALE:	N.T.S.
DRAWN BY:	JOSEPH MONTUORI SET
DATE:	7-28-20
CHECKED BY:	JDM
PROJECT #:	1578

© COPYRIGHT
ALL DRAWN AND WRITTEN INFORMATION APPEARING
HEREIN SHALL NOT BE DUPLICATED, DISCLOSED, OR
OTHERWISE USED WITHOUT THE EXPRESSED WRITTEN
CONSENT OF PEACE OF MIND FIRE & SECURITY