



Design Alarms LLC
 3642 South Creek Road
 Knoxville, TN 37920
 865-394-9992 (office)
 865-621-9927 (cell)



© Copyright 2020+ Design Alarms LLC
 All Rights Reserved


3315 Old Plantation Way

Alan and Kathy Henderson Plans

Blount County, TN

Bonus Floor Switch and Lighting Plan

Sweet Grass Plantation Subdivision

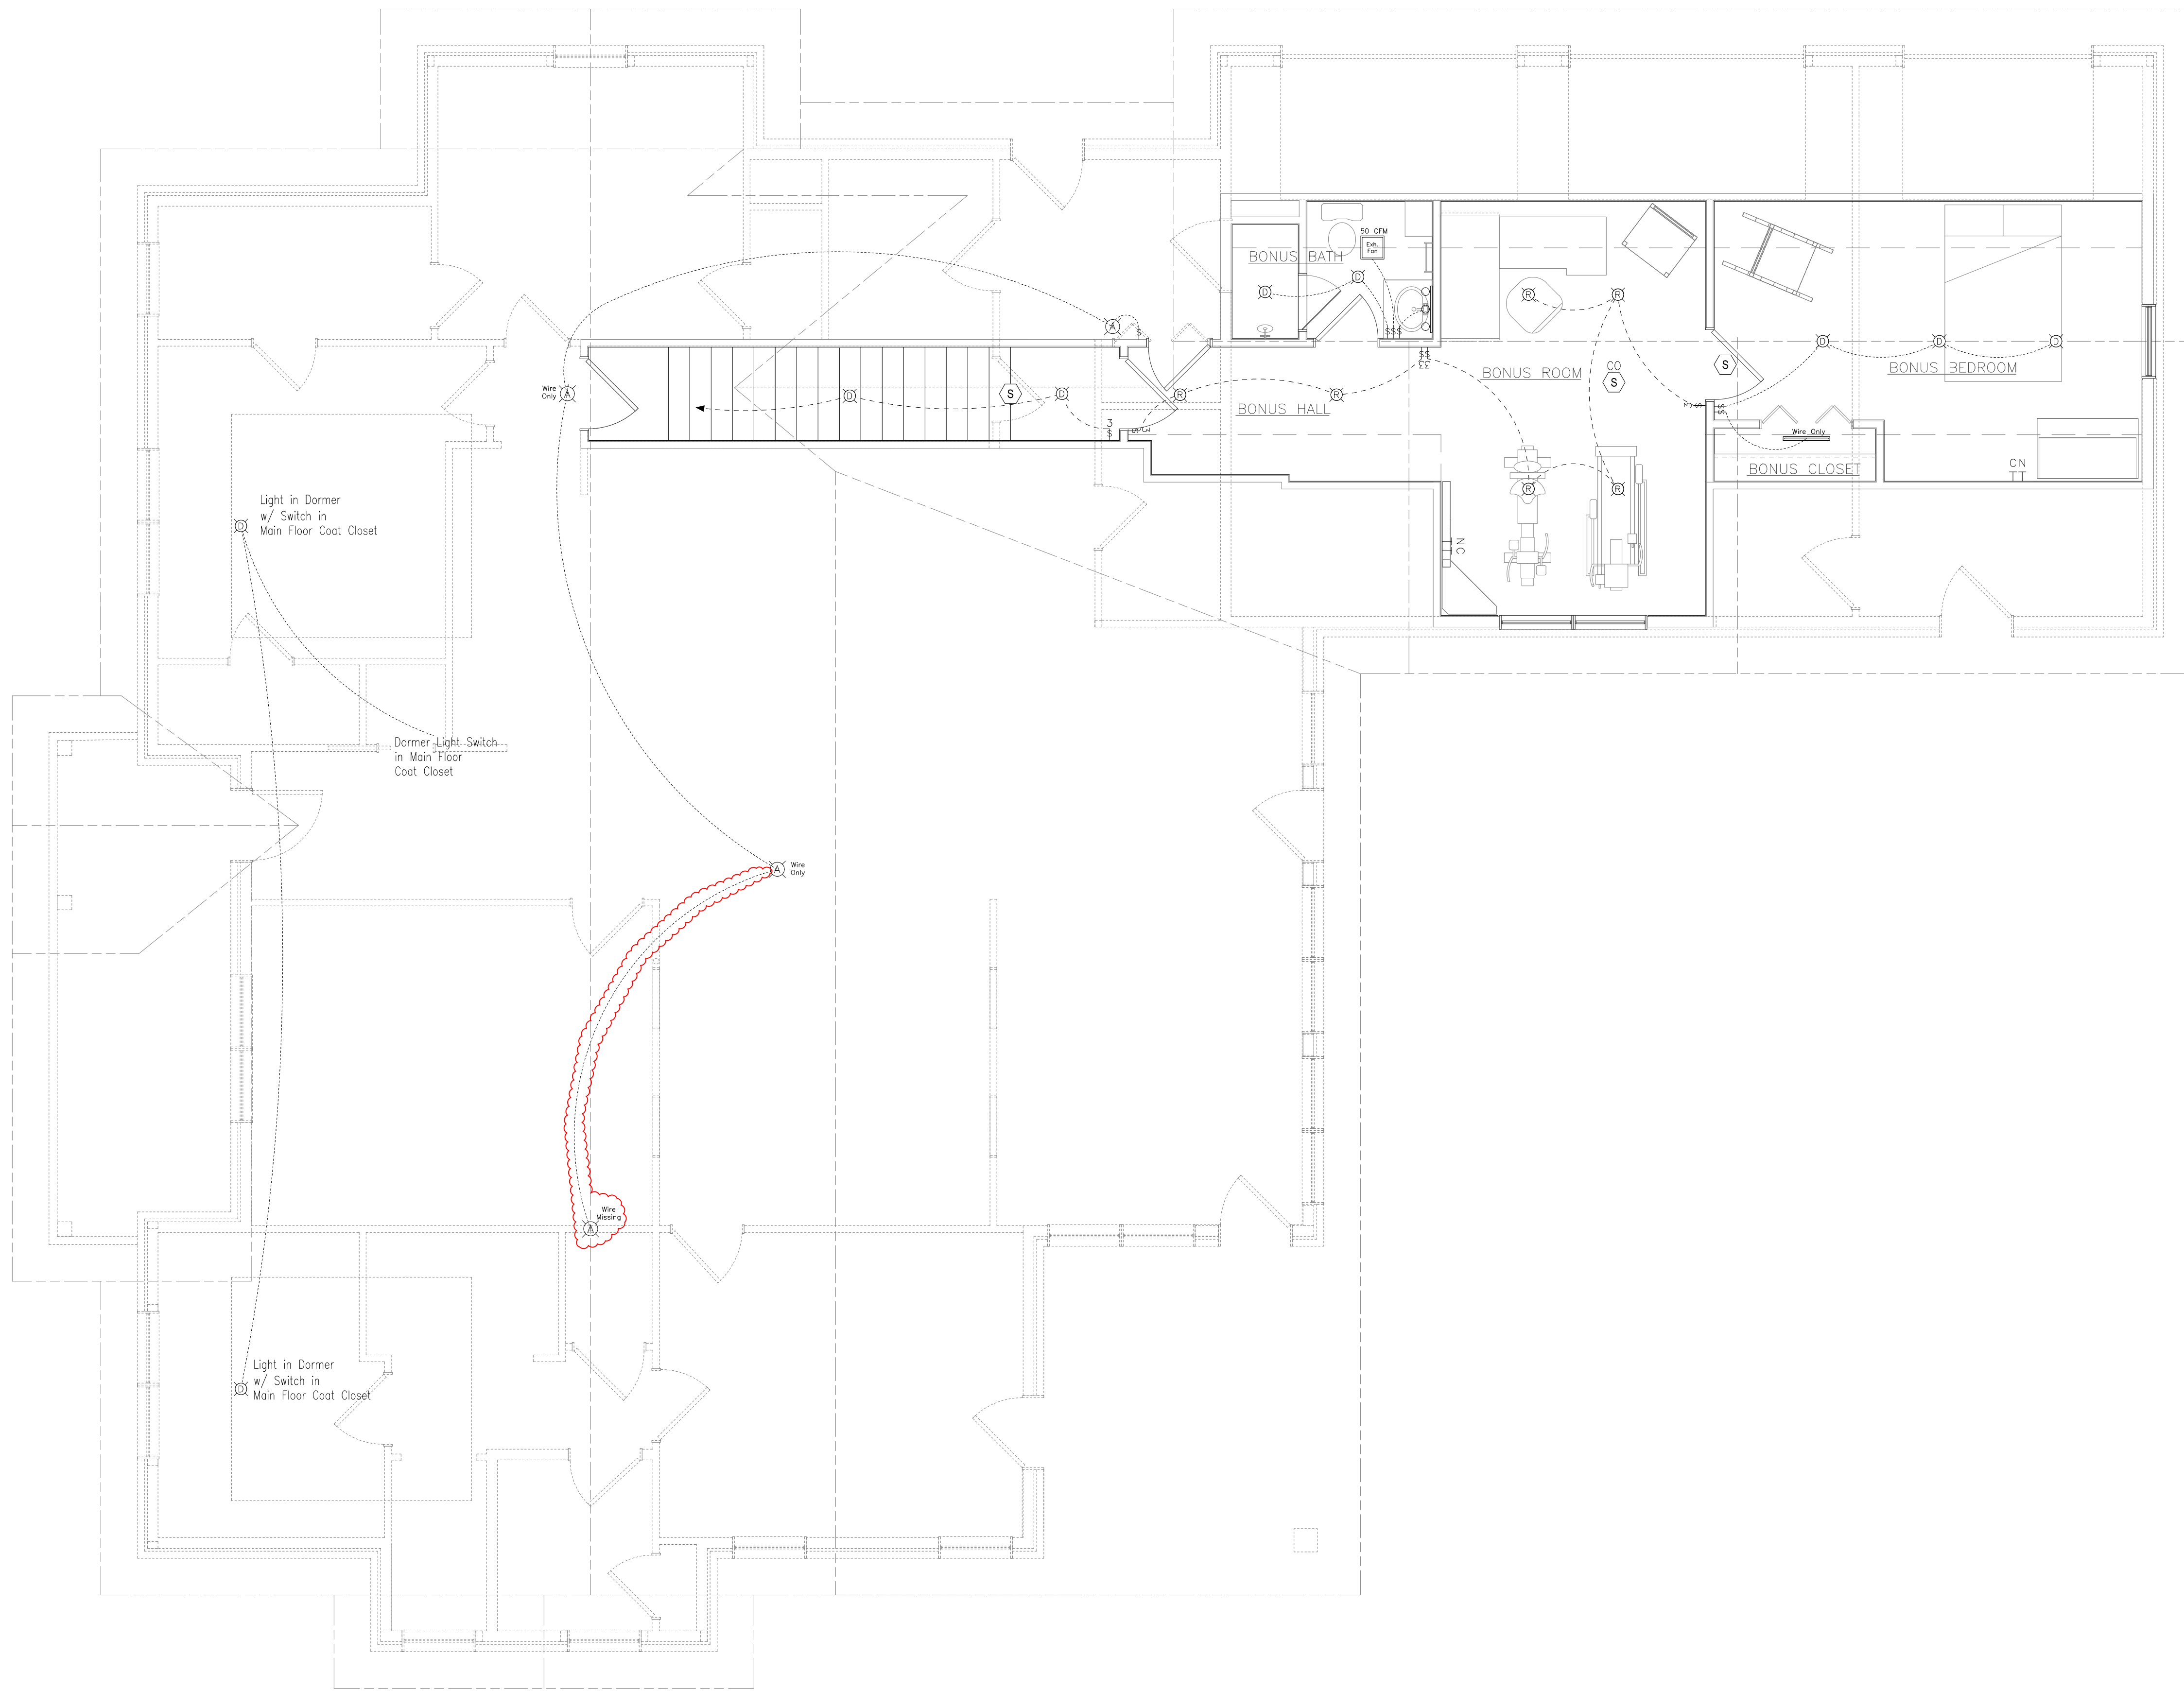

Wire Legend

- Single Switch Wire
- 3-Way Switch Wire
- 4-Way Switch Wire

Switches

Qty	Switch Type	Symbol
6	Single-Pole Switch	Ⓢ
5	3-way Switch	Ⓢ-L

Lighting

Qty	Light Type	LED Bulbs	Location	Symbol
9	Disc Lights	X	Bonus - Stairs, Hall, Room, Bath, Bedroom, Closet	Ⓛ
6	Recessed Lights	X	Bonus - Stairs, Hall, Room, Bath, Bedroom, Closet	Ⓛ-R
4	Porcelain Lampholder	X	Attic	Ⓛ-A
1	24" LED	X	Bonus Bedroom Closet	Ⓛ-B
1	Vanity Horizontal	X	Bonus Bath	Ⓛ-V
1	Bath Exhaust Fan 50 CuFt		Bonus Bath	Ⓛ-E

REVISIONS

DATE BY

SHEET

Bonus Light

DESIGNED: ARH

DATE: 8/18/20

SCALE: 1/4"=1'-0" at 24x36

DRAWING: Henderson Elec Light

PROJECT NO: